




Do not scale off this drawing
All dimensions should be checked on site
E. & O.E.

© ACCESS IRRIGATION LTD

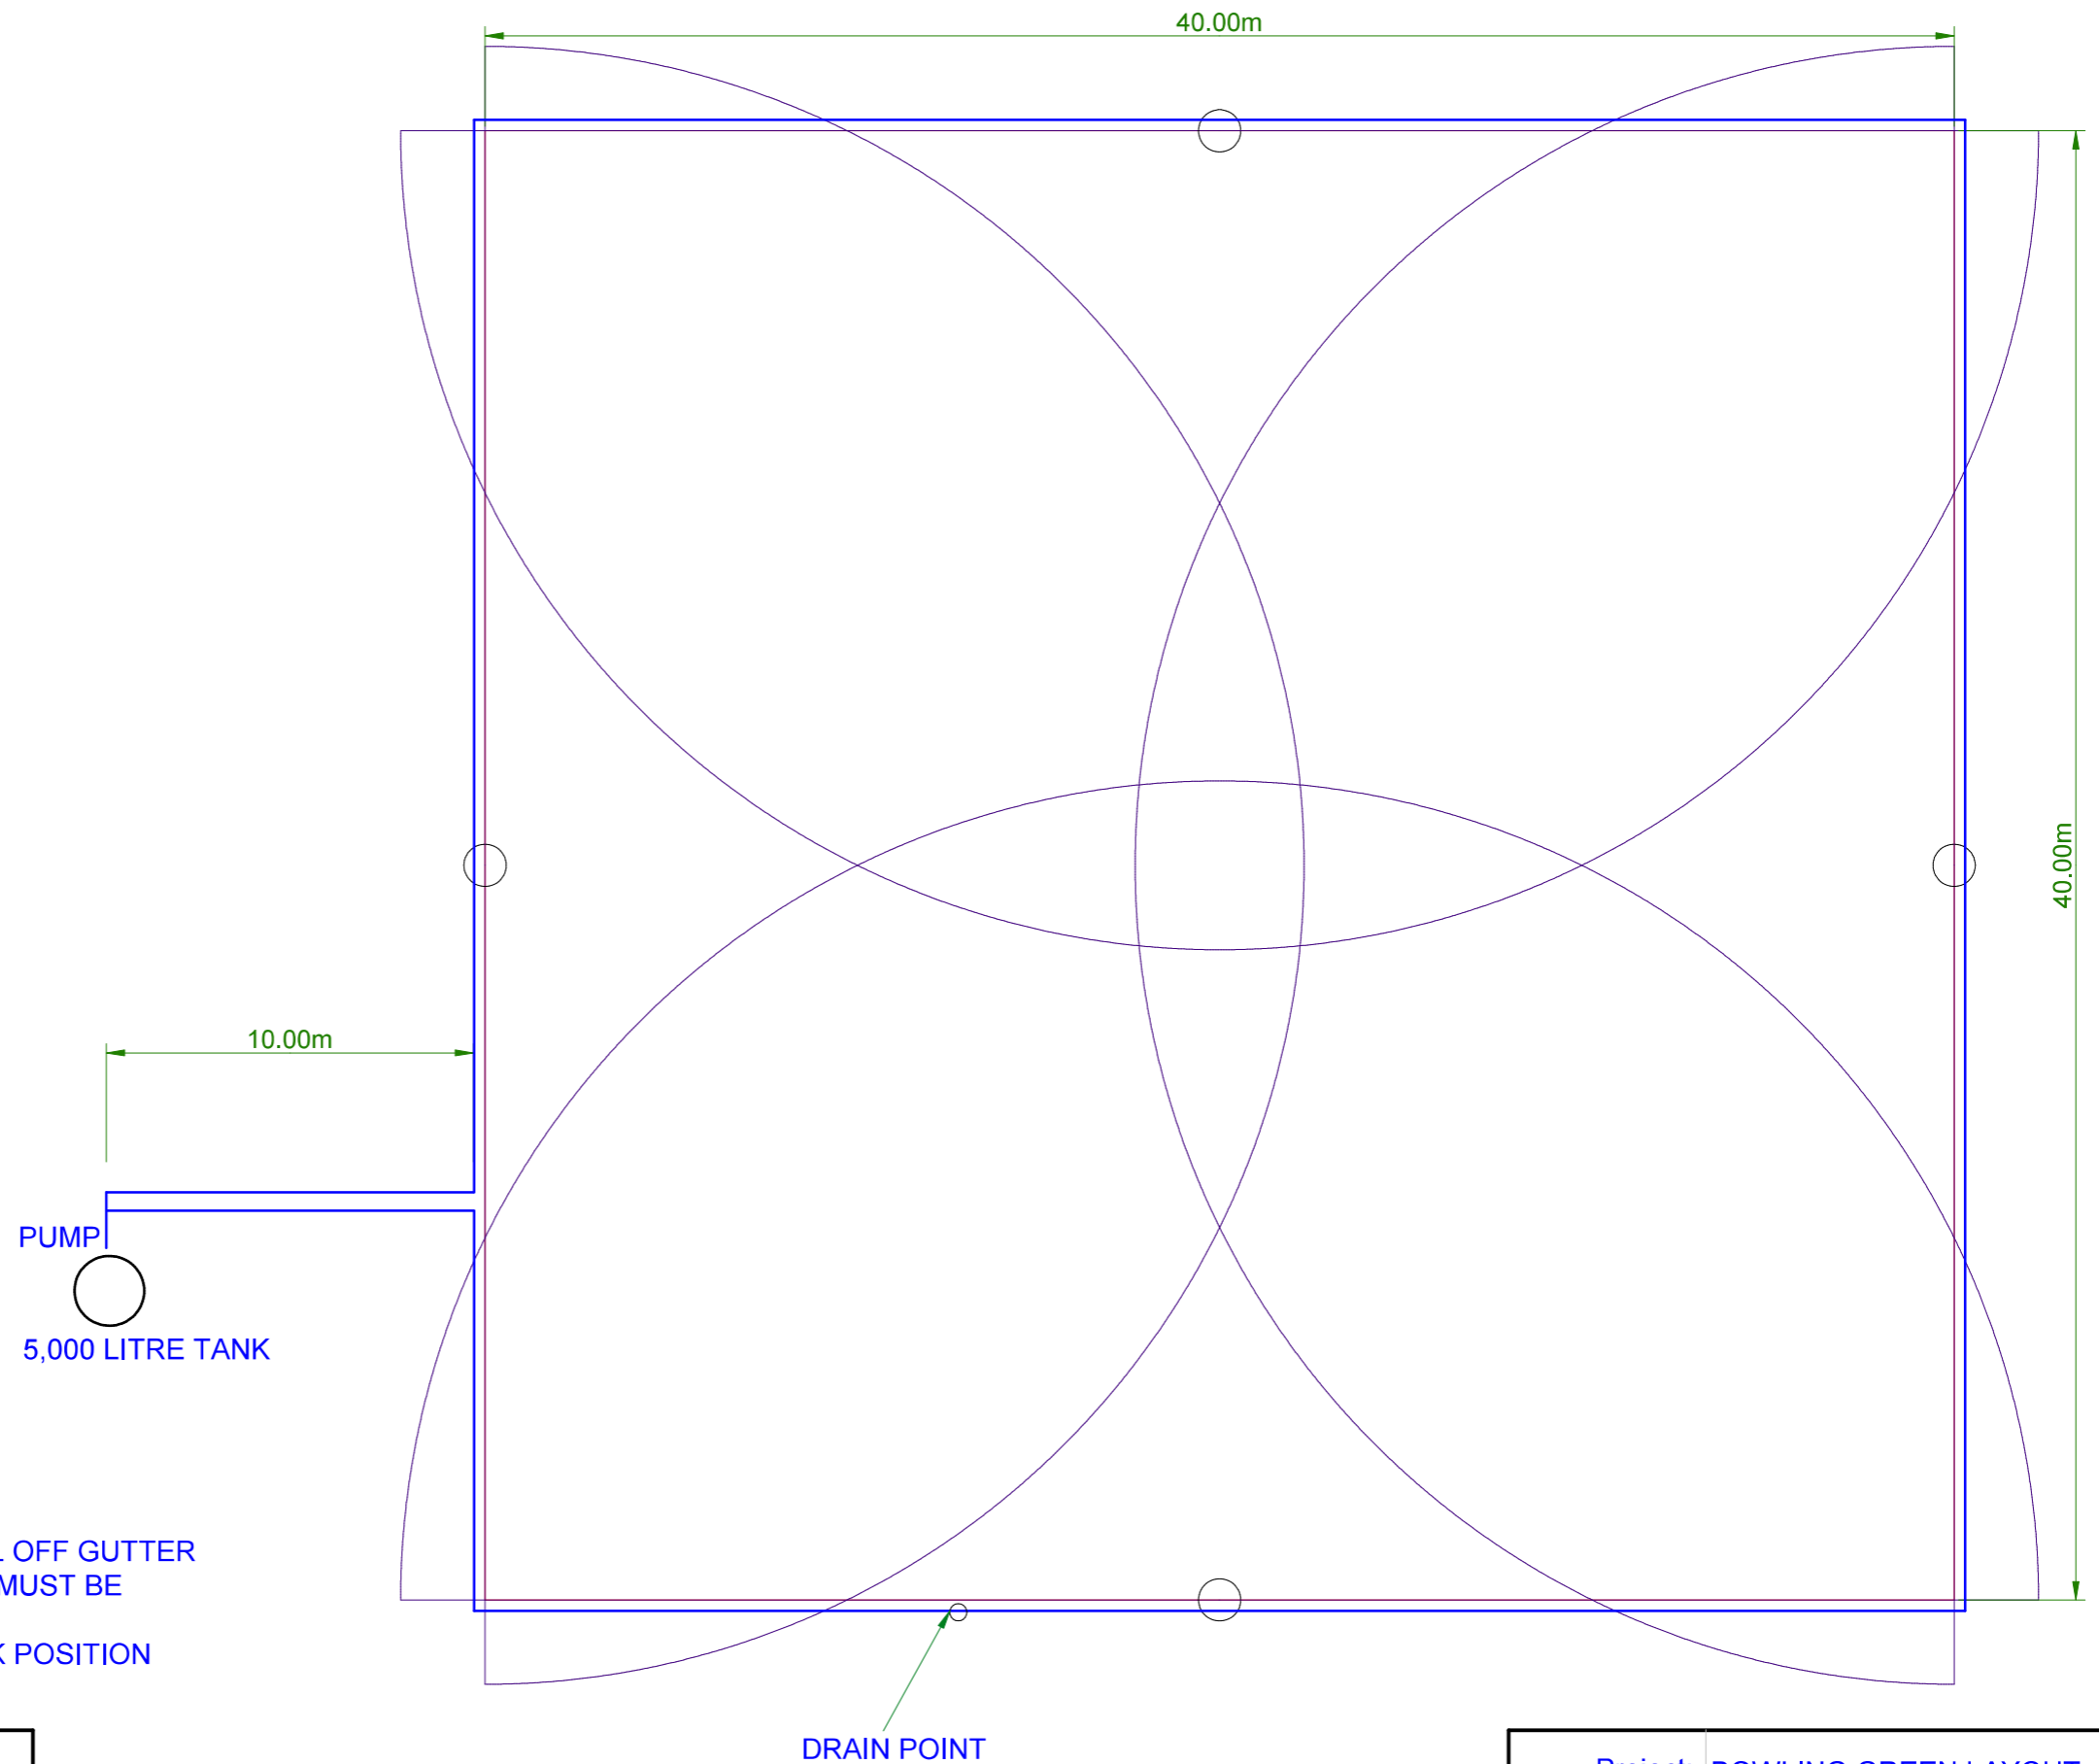

TANK POSITION MAX 10m FROM GREEN
PIPE RING MAIN TO BE TRENCHED INTO ROLL OFF GUTTER
PUMP POSITION ADJACENT TO TANK - PUMP MUST BE PROTECTED FROM THE ELEMENTS
MAINS WATER AND POWER NEEDED AT TANK POSITION


KEY	
	MDPE UNDERGROUND PIPE
	POP-UP SPRINKLER POSITION

Project:	BOWLING GREEN LAYOUT
Title:	SPRINKLER LAYOUT
Scale:	
Date:	24 - Oct - 2019
Drawing No:	Rainbird 955 layout



Do not scale off this drawing
All dimensions should be checked on site
E. & O.E.

© ACCESS IRRIGATION LTD

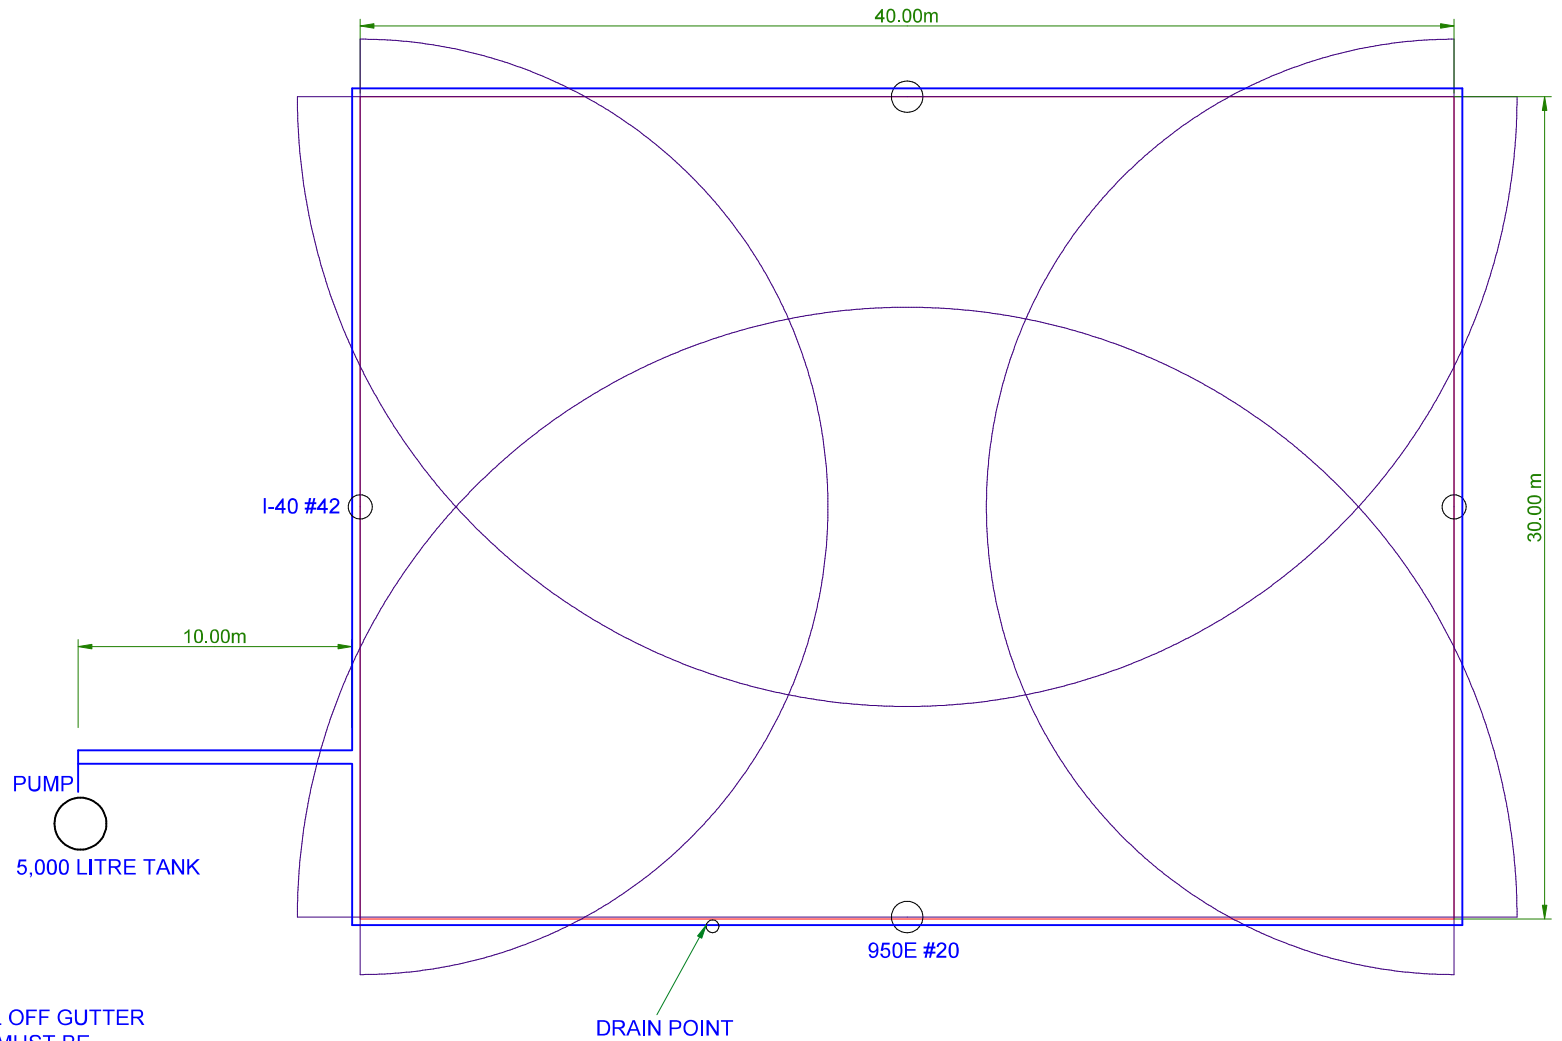

TANK POSITION MAX 10m FROM GREEN
PIPE RING MAIN TO BE TRENCHED INTO ROLL OFF GUTTER
PUMP POSITION ADJACENT TO TANK - PUMP MUST BE PROTECTED FROM THE ELEMENTS
MAINS WATER AND POWER NEEDED AT TANK POSITION

KEY	
	MDPE UNDERGROUND PIPE
	POP-UP SPRINKLER POSITION

Project:	BOWLING GREEN LAYOUT
Title:	SPRINKLER LAYOUT 40m x 30m
Scale:	
Date:	15 - Sep - 2020
Drawing No:	Rainbird 955 layout